



N:\SD9039600\CADD\USFS\CIVIL\GP04

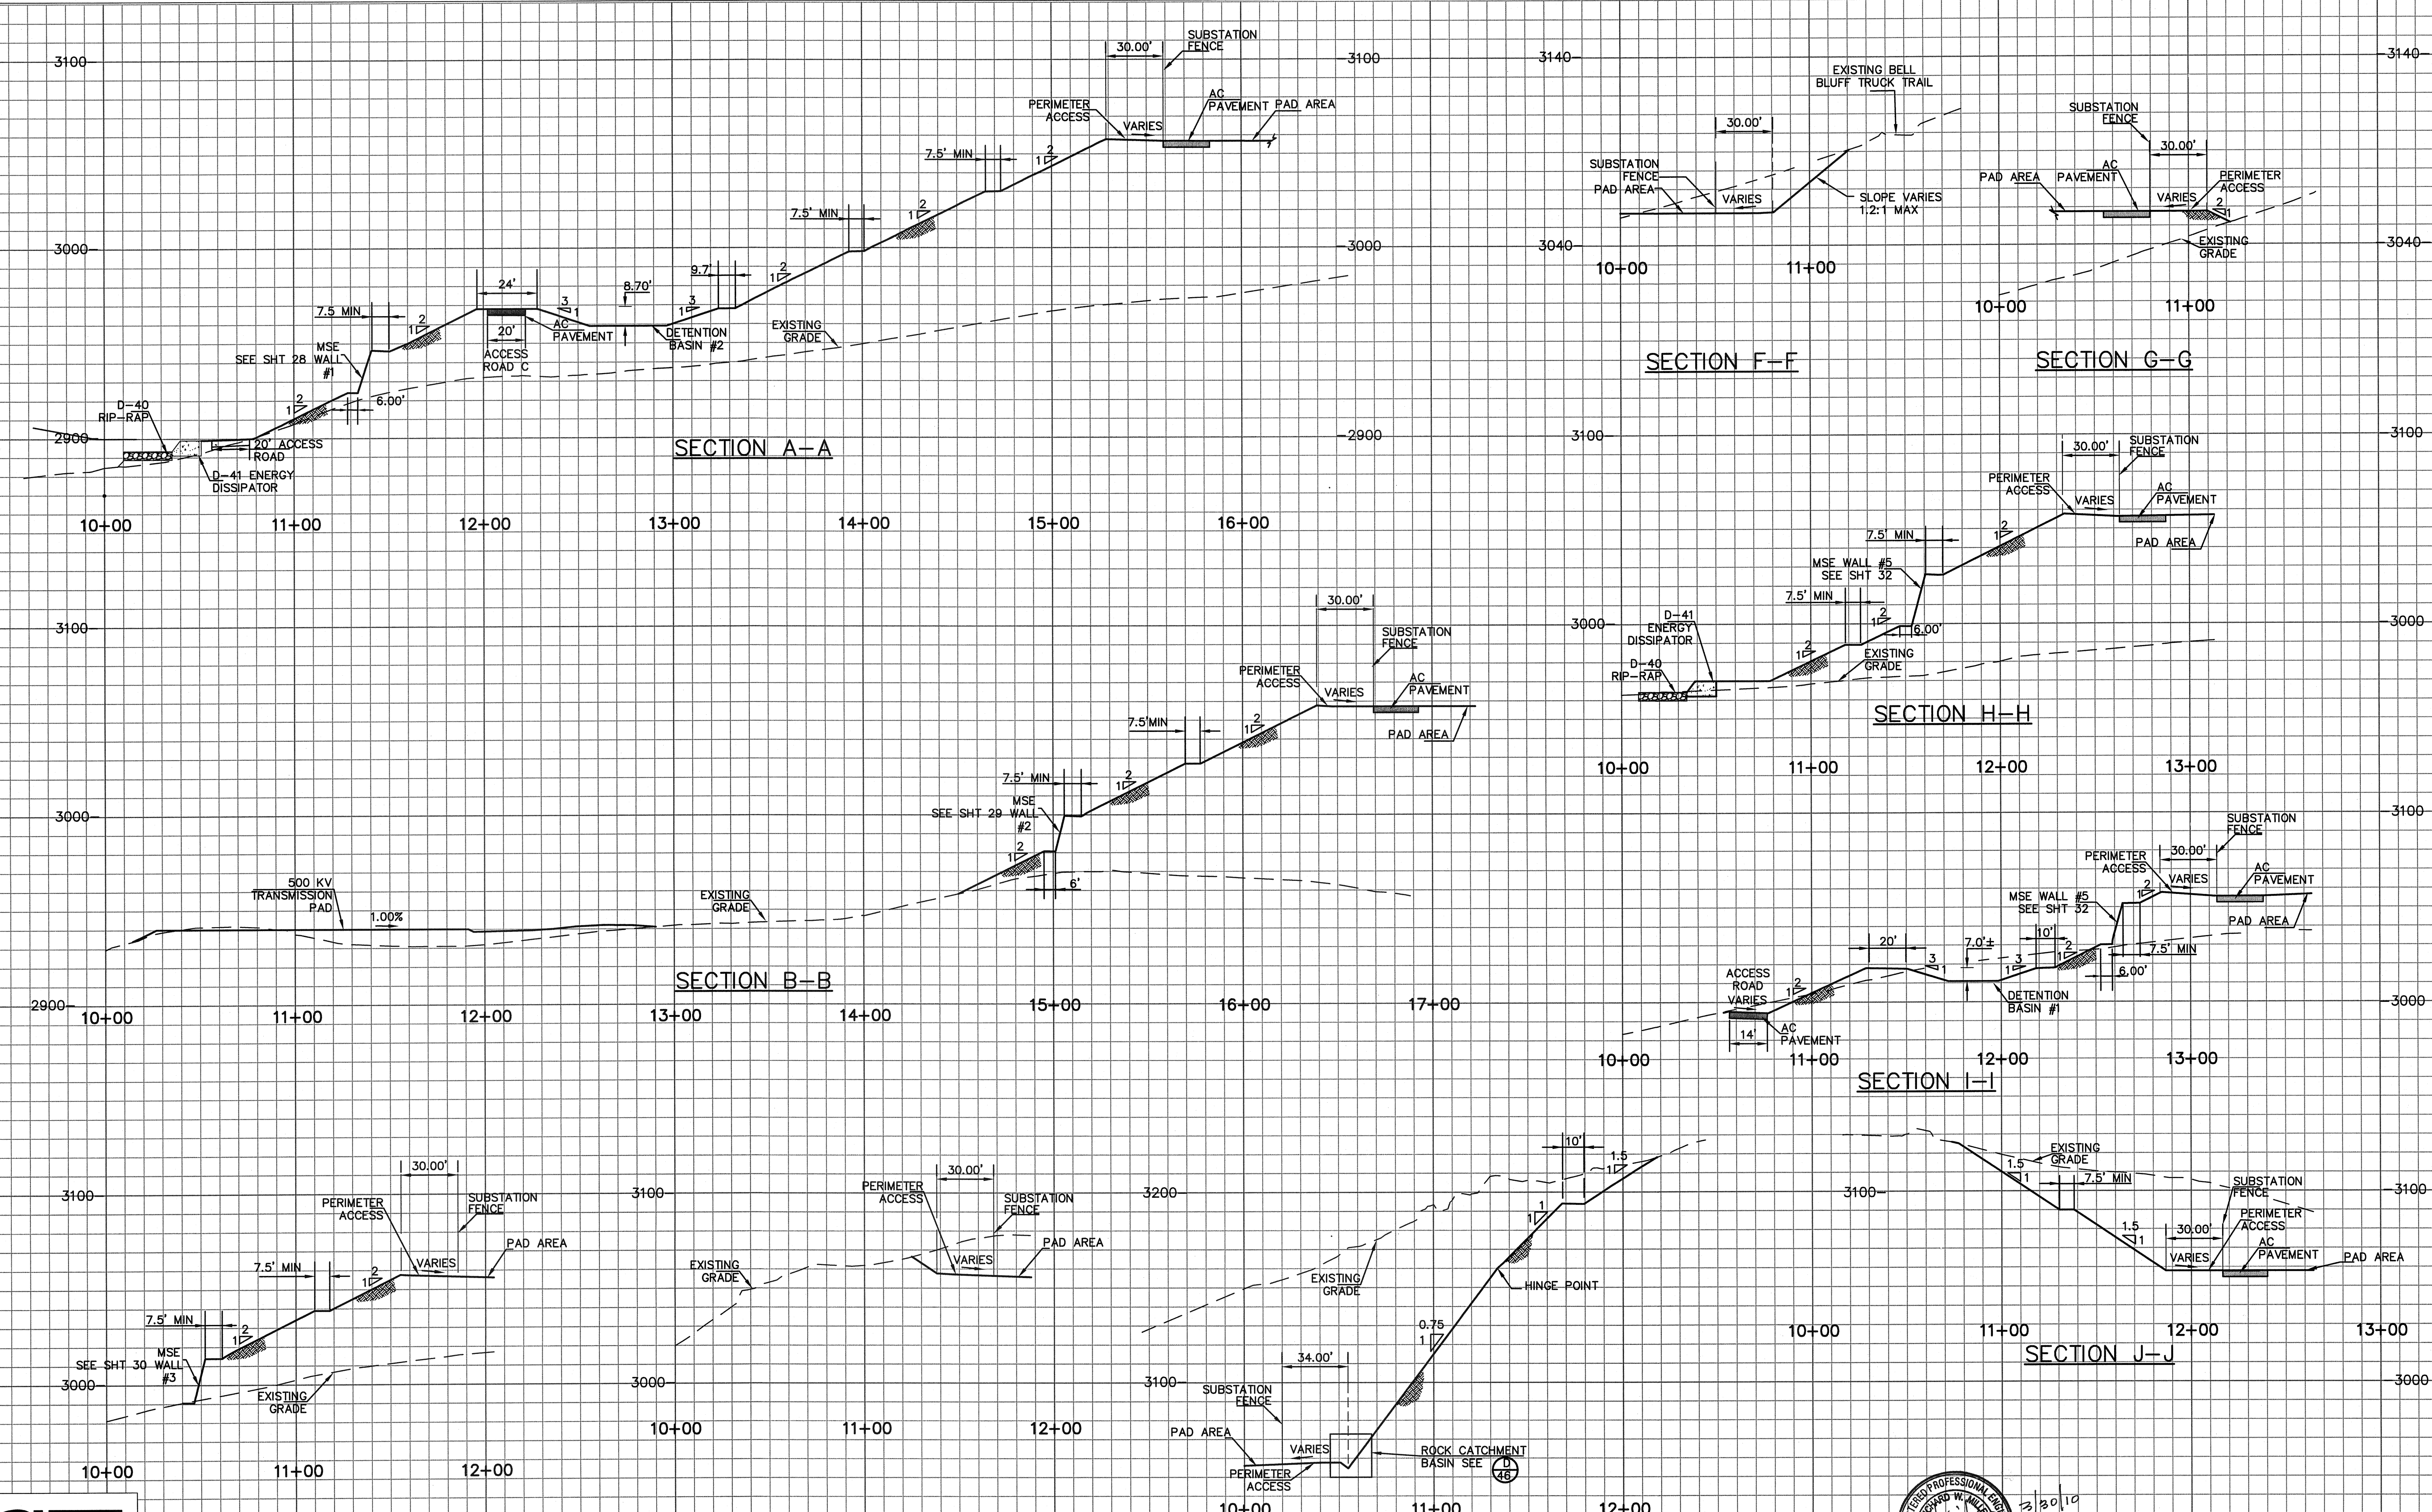

REVISIONS

NO.	WORK DONE	DATE	BY	APP'D	NO.	WORK DONE	DATE	BY	APP'D	NO.	WORK DONE	DATE	BY	APP'D	NO.	WORK DONE	DATE	BY	APP'D	NO.	

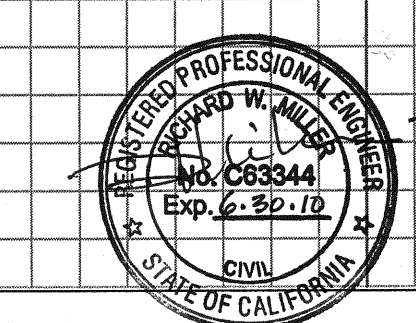

SAN DIEGO GAS & ELECTRIC COMPANY
 SAN DIEGO, CALIFORNIA

SUNCREST SUBSTATION
 SITE PLAN SECTIONS

DRAWN BY: MJ DATE: 3/24/10 SCALE: 1"=40' W.D.: - REV.: 0
 CHECKED BY: RWM DATE: -
 APPROVED BY: CR DATE: - SHEET 4 OF 66
 CAD NO.: GP04 PLOT SCALE: 1=1

SCR-C-004